


OCRC
5505 S. ORANGE AVE.
EDGEWOOD, FL

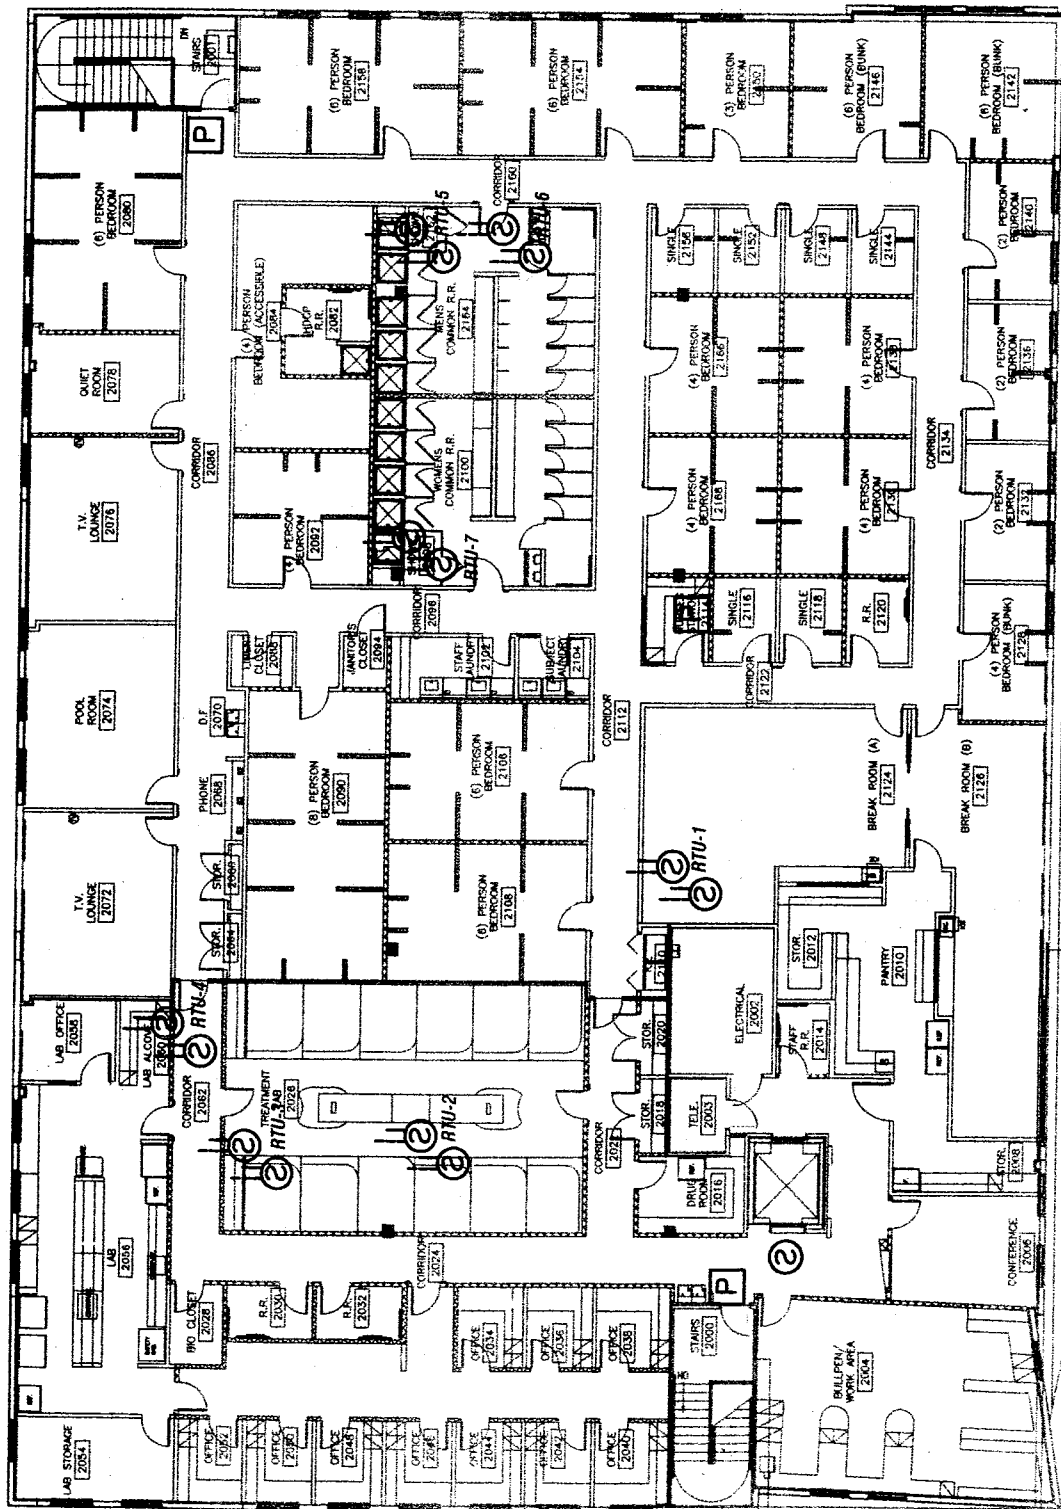

SYMBOL	DESCRIPTION
FCP	FIRE ALARM CONTROL PANEL (FCP)
FSA	FIRE ALARM SYSTEM ANNUN. (FSA)
P	MANUAL STATION
⊙	PHOTOELECTRIC SMOKE DETECTOR
⊙	HEAT DETECTOR
⊙	SPRINKLER WATER FLOW SWITCH
⊙	SPRINKLER TAMPER SWITCH
⊙	DUCT DETECTOR

FIRE ALARM ZONE MAP - SECOND FLOOR
Scale: N.T.S.

